

LEGEND:

- VOR / DME
- GLIDE PATH
- LOCALIZER

ISS	DRN	AMENDMENTS	APPD	DATE
1	TH	Original Issue	JT	28.04.22

CAUTION :
 ANY PERSON INTENDING TO USE ANY INFORMATION IN THIS DRAWING MUST READ THIS NOTICE

This drawing has been prepared for the sole use of Perth Airport Pty Ltd (Perth Airport). Any person intending to rely on any information contained in this drawing must independently verify that information by conducting appropriate physical measurements or surveys on the site in question. In particular, all services should be physically located and before any building activity is commenced on Perth Airport lands a permit must be obtained from the Perth Airport Building Controller. Copyright in this drawing is owned by Perth Airport. Reproduction in any form is prohibited without the prior permission in writing of Perth Airport.

AIRSERVICES AUSTRALIA

NAVIGATION AID CLEARANCES - Existing

Notes TAR and lighting planes not shown


MICROSTATION FILE :
 G:_PLANNING\Reference Files\AerodromeManual\FS4395.dgn

DRAWN	APPROVED	DATE
TH	JT	28/04/22

SIZE	DRAWING No.
A1	SCALE
	1:10000
	SHEET
	1 of 2

Perth Airport

0 100 200 500 1000

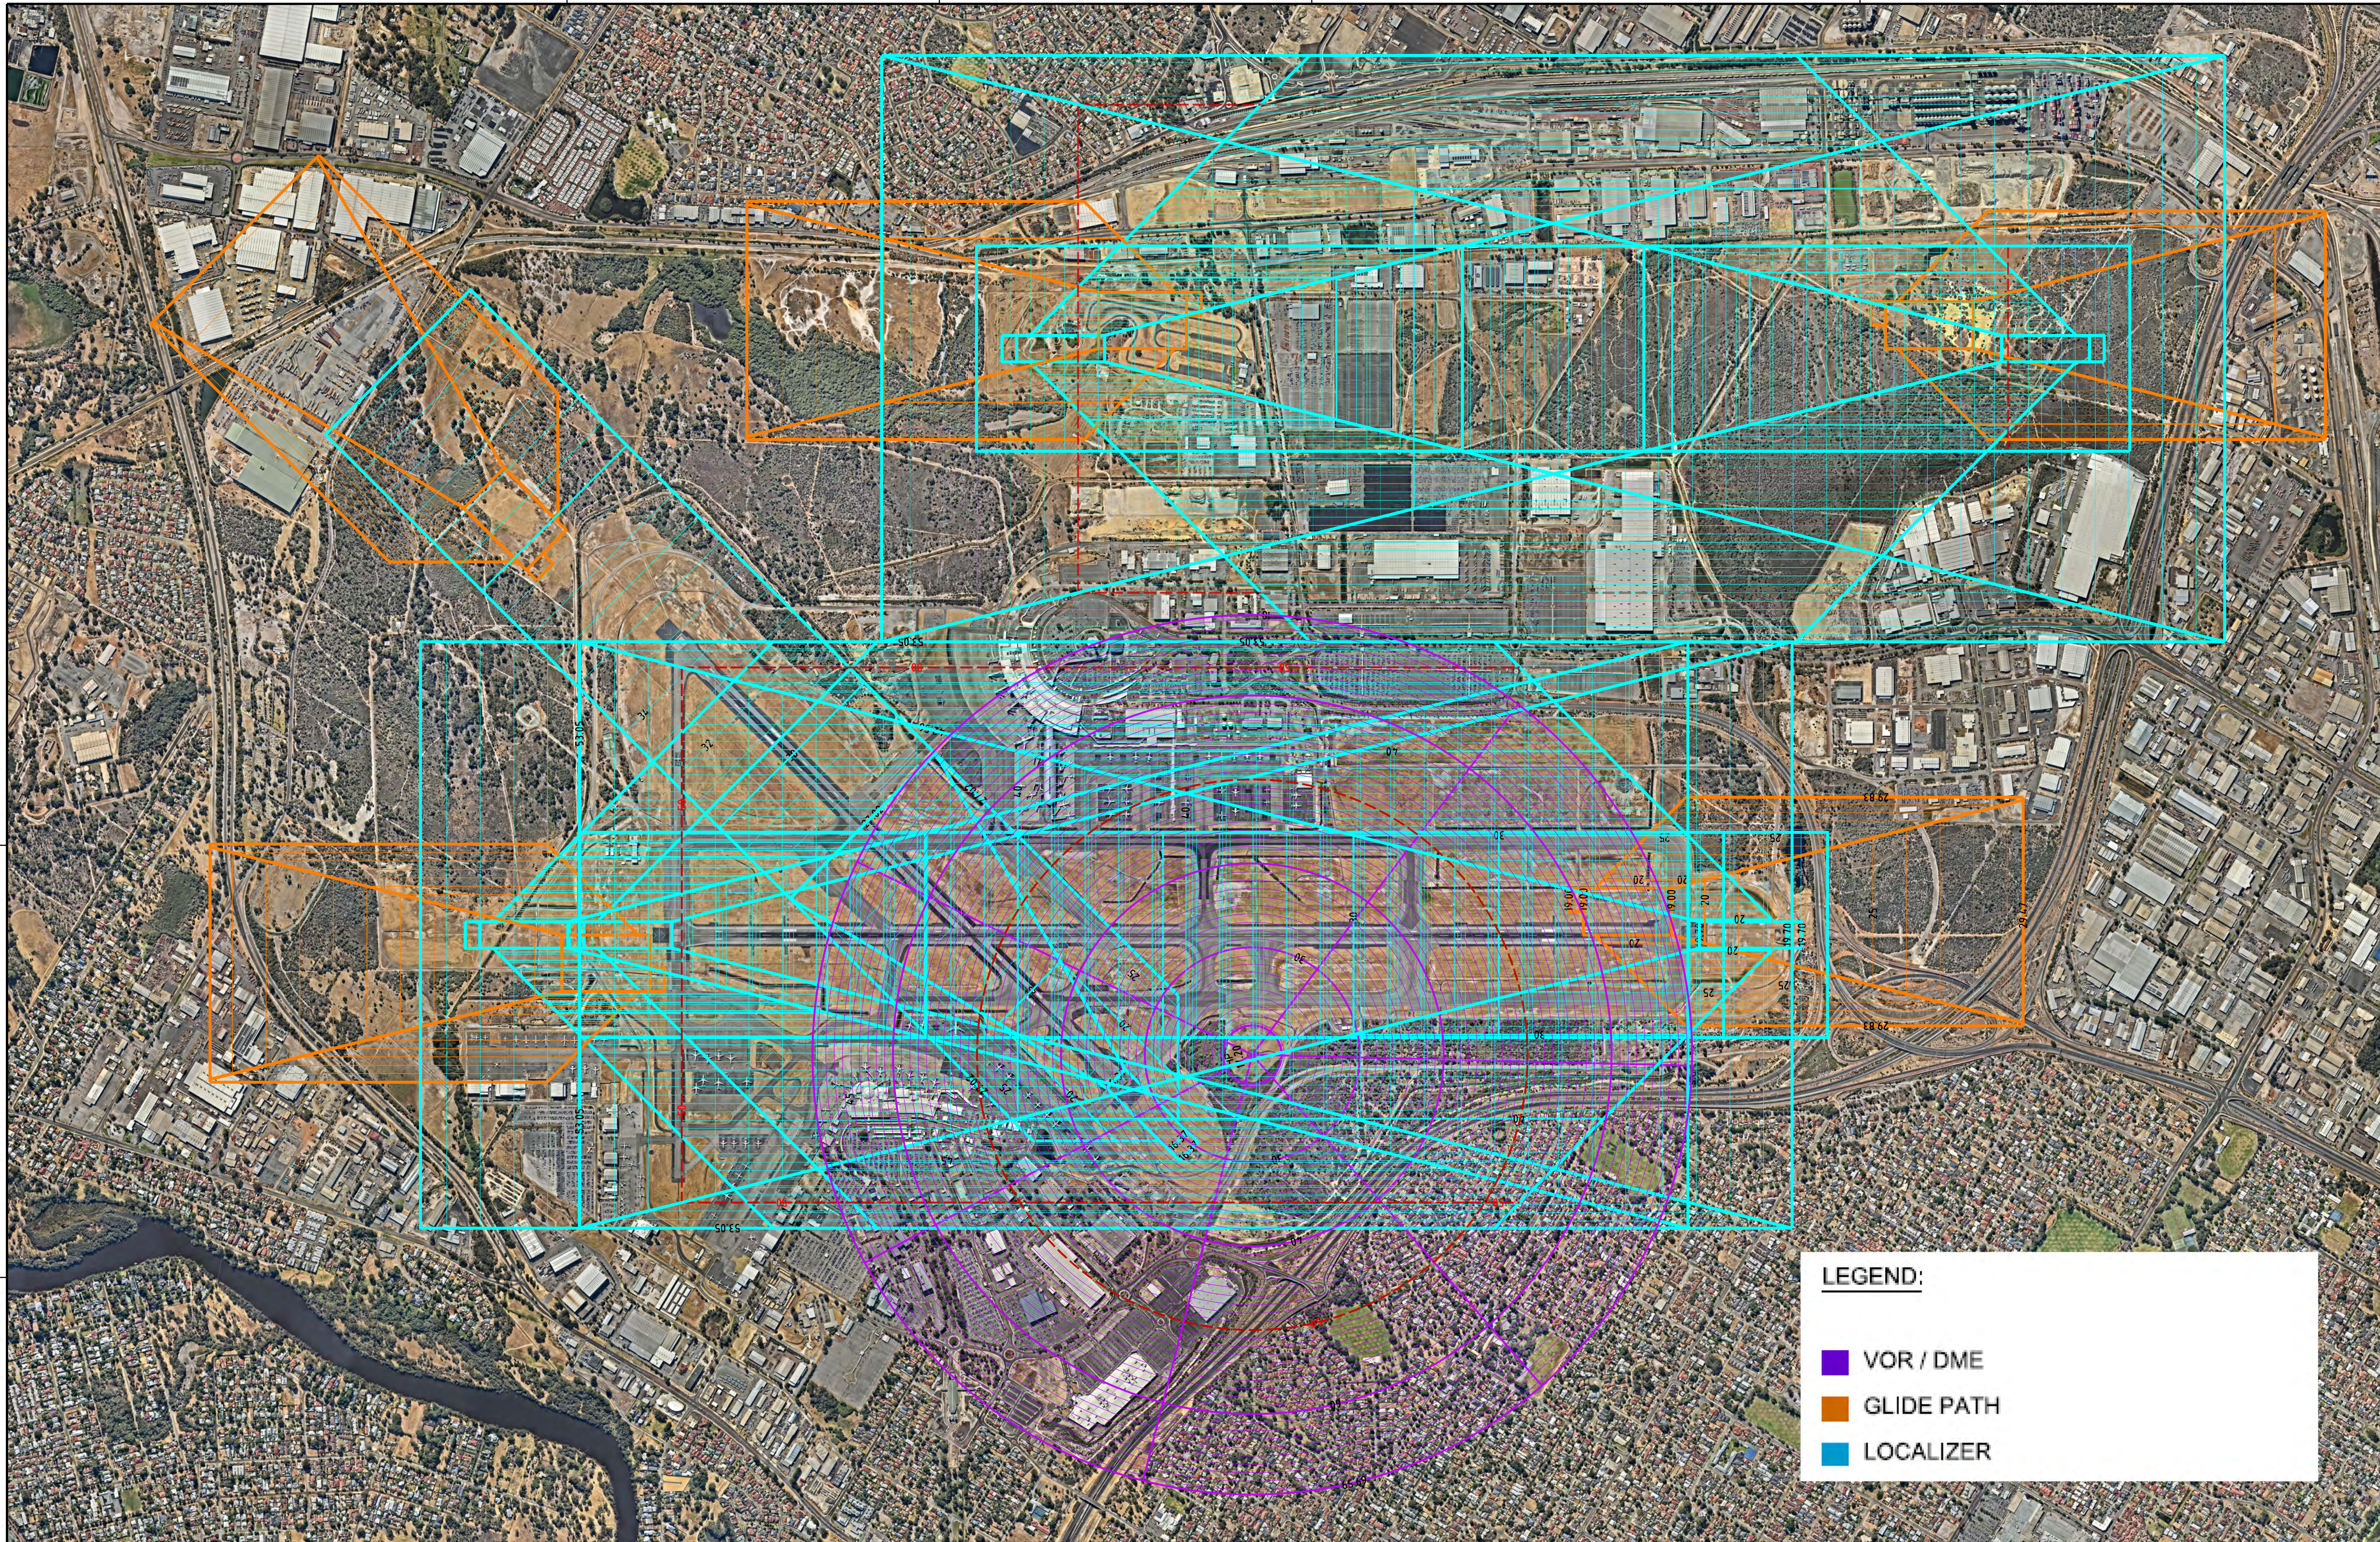

LEGEND:

- VOR / DME
- GLIDE PATH
- LOCALIZER

ISS	DRN	AMENDMENTS	APPD	DATE
1	TH	Original Issue	JT	28.04.22

CAUTION :
 ANY PERSON INTENDING TO USE ANY INFORMATION IN THIS DRAWING MUST READ THIS NOTICE

This drawing has been prepared for the sole use of Perth Airport Pty Ltd (Perth Airport). Any person intending to rely on any information contained in this drawing must independently verify that information by conducting appropriate physical measurements or surveys on the site in question. In particular, all services should be physically located and before any building activity is commenced on Perth Airport lands a permit must be obtained from the Perth Airport Building Controller. Copyright in this drawing is owned by Perth Airport. Reproduction in any form is prohibited without the prior permission in writing of Perth Airport.

AIRSERVICES AUSTRALIA

NAVIGATION AID CLEARANCES - Ultimate

Notes TAR and lighting planes not shown

MICROSTATION FILE :
 G:_PLANNING\Reference Files\AerodromeManual\FS4395.dgn

DRAWN	APPROVED	DATE
TH	JT	28/04/22

SIZE	DRAWING No.
A1	SCALE
	1:10000
	SHEET
	2 of 2

Perth Airport

0 100 200 500 1000